 
 
 





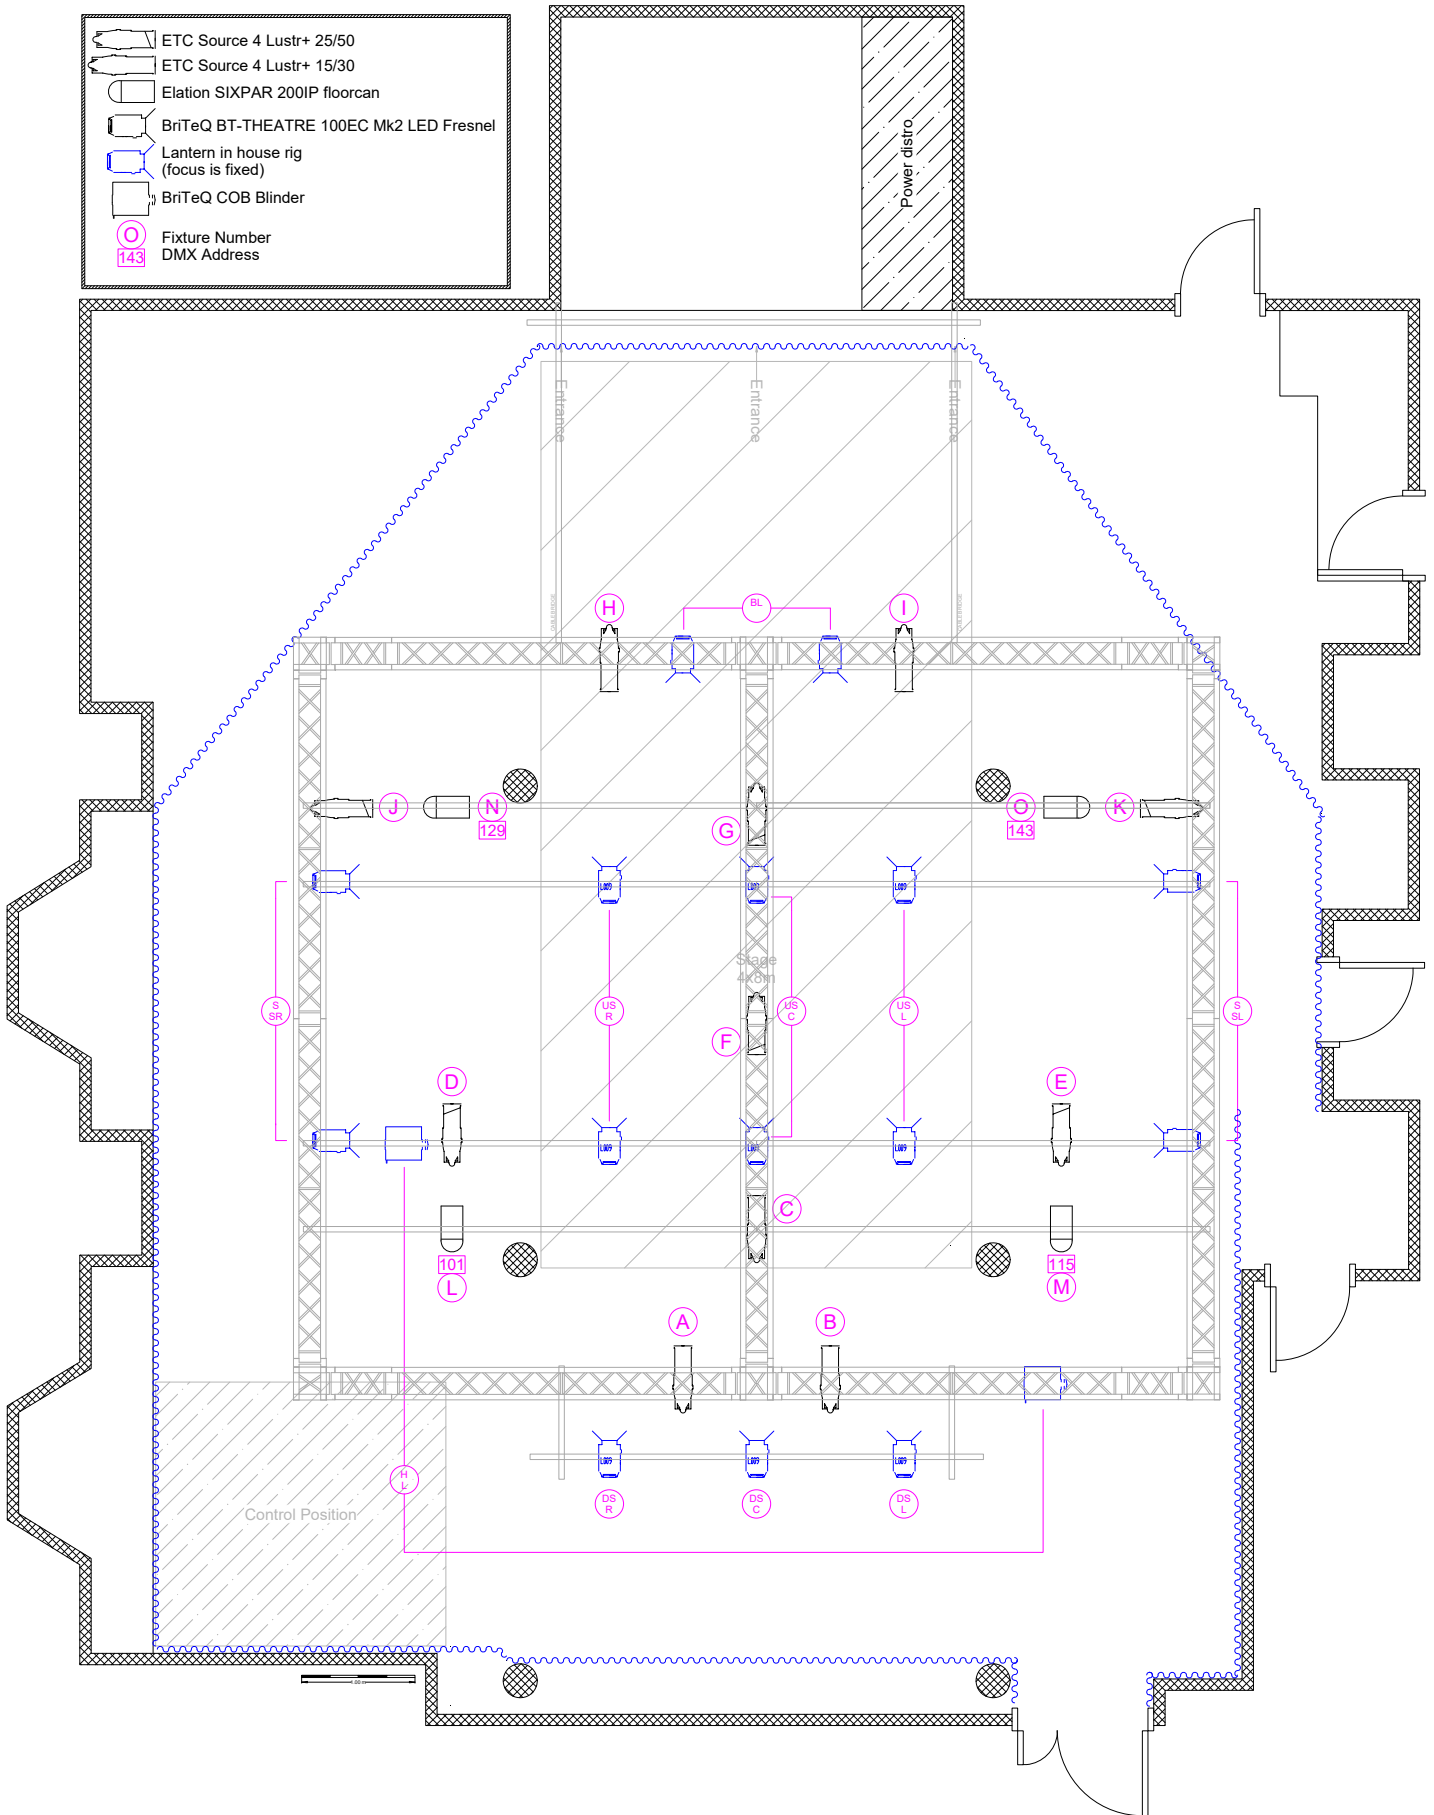


-  ETC Source 4 Lustr+ 25/50
-  ETC Source 4 Lustr+ 15/30
-  Elation SIXPAR 200IP floorcan
-  BriTeQ BT-THEATRE 100EC Mk2 LED Fresnel
-  Lantern in house rig (focus is fixed)
-  BriTeQ COB Blinder
-  Fixture Number
-  DMX Address



VENUE				Venue 45	
TITLE				LIGHTING Plan	
SIZE	DWG CODE	DWG NO	REV		
A4		theSpaceUK-VP-01-18	24.2		
SCALE	15mm = 1m			SHEET	