
 


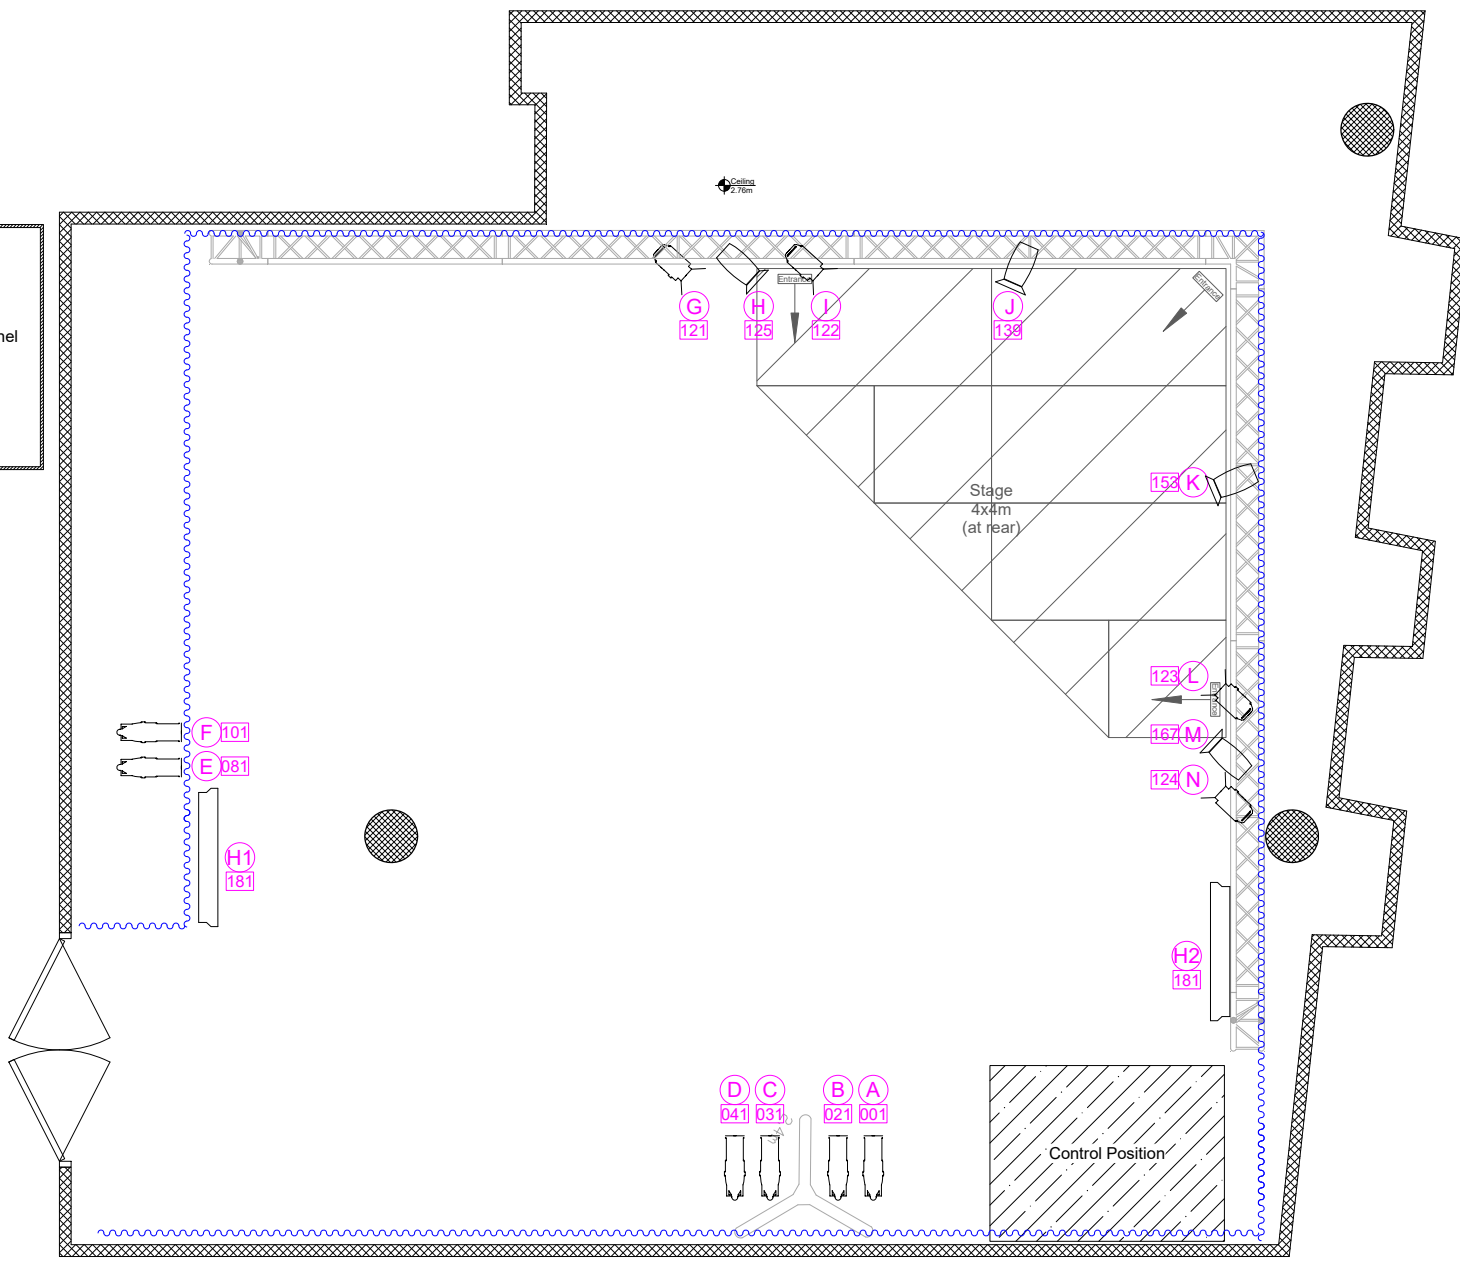
	Robe Perfect
	LED Profile
	Elumen8 LED Fresnel
	PixelLine
	Fixture Number DMX Address



1.00 m

VENUE			
theSpace @ Surgeons' Hall			
TITLE			
Theatre 1 LIGHTING Plan			
SIZE	CAGE CODE	DWG NO	REV
A4		theSpaceUK-VP-06-18	24.1
SCALE	SHEET		