


Dimmer 1: 1
 Dimmer 2: 7
 Dimmer 3: 12
 Dimmer 4: 18

Dimmers
 Power distro

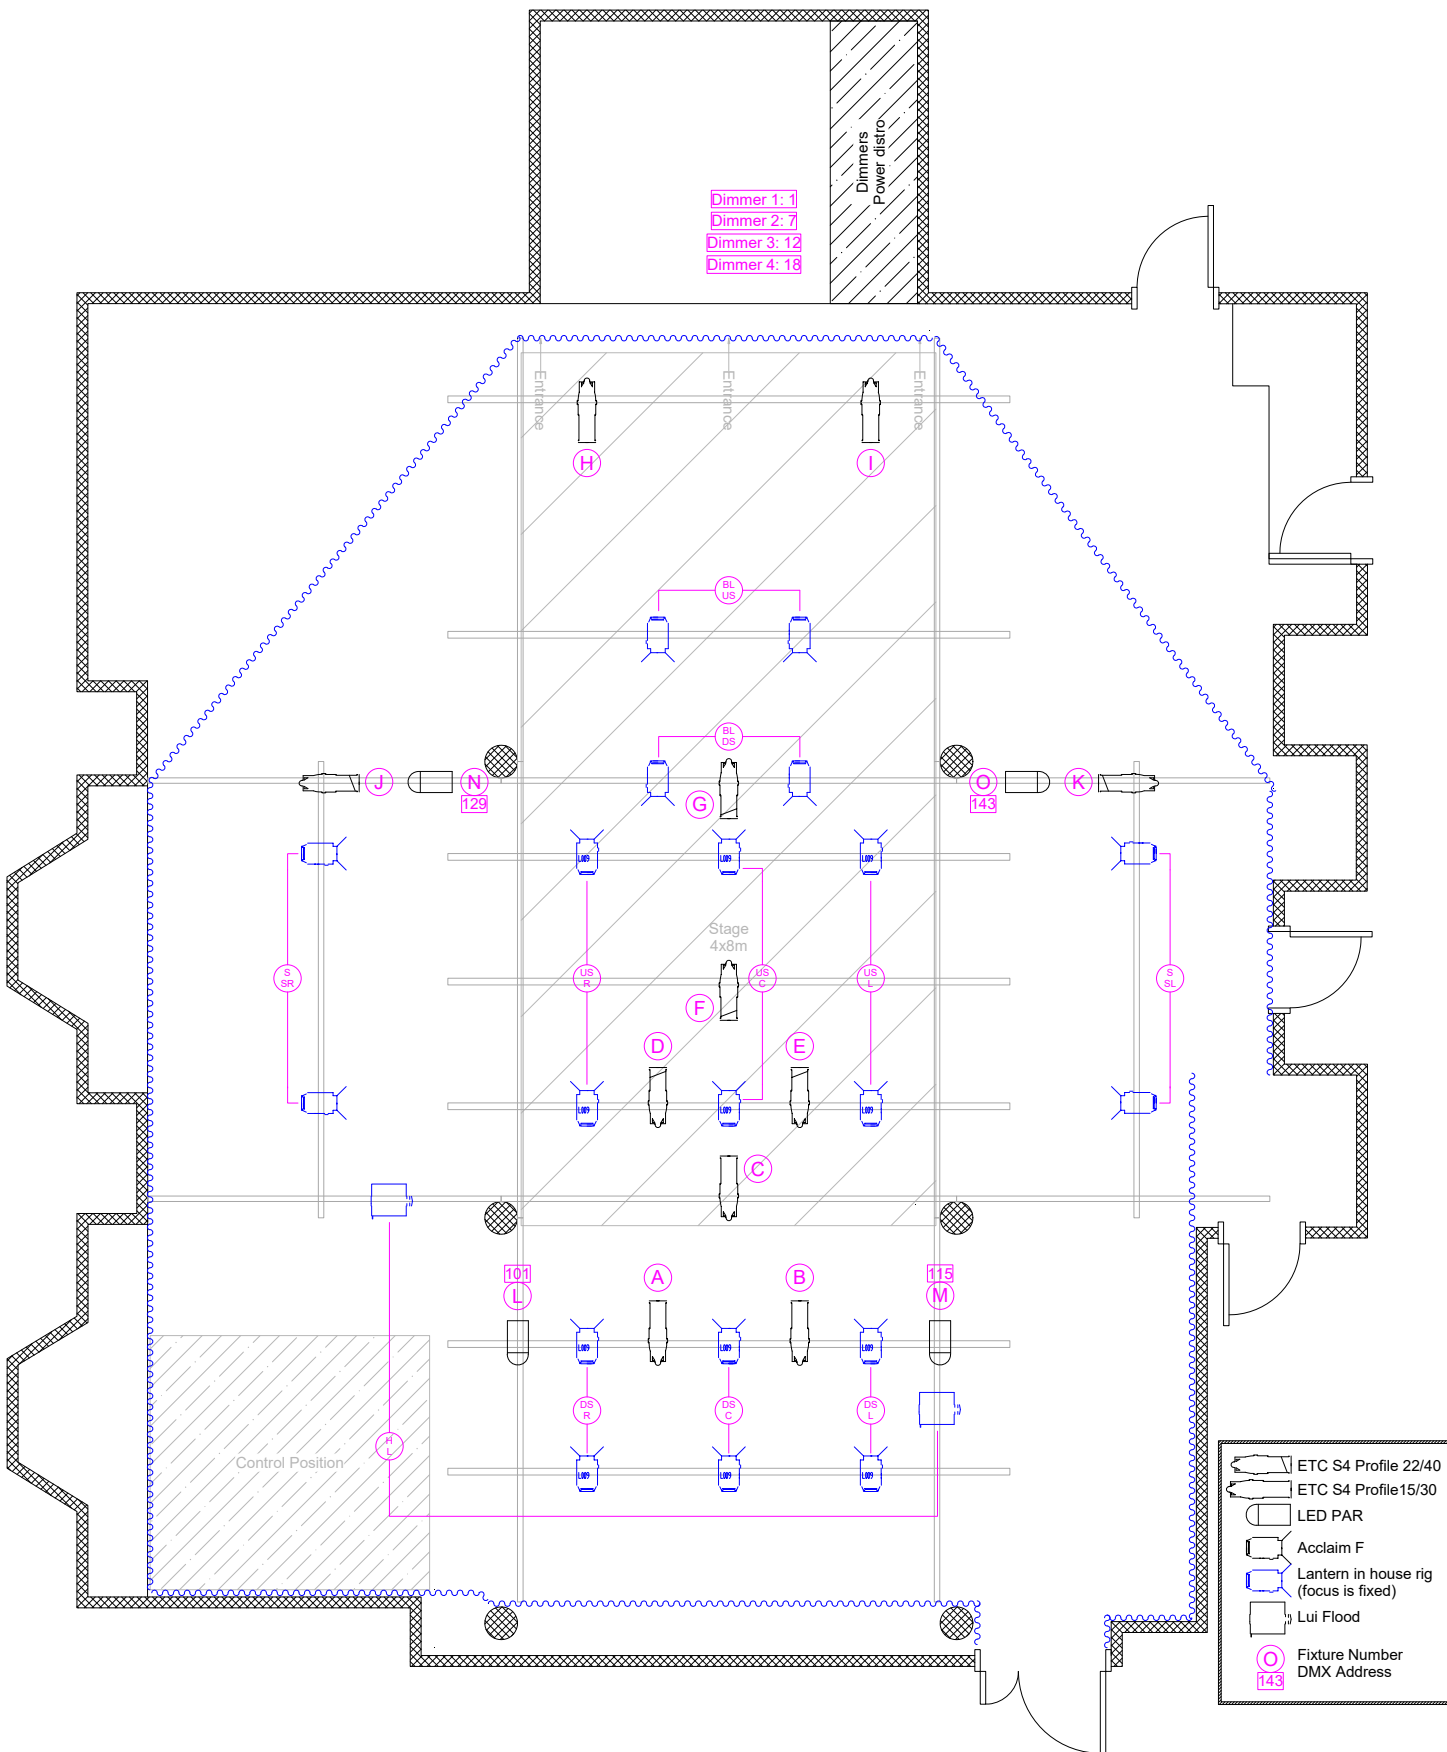

- ETC S4 Profile 22/40
- ETC S4 Profile 15/30
- LED PAR
- Acclaim F
- Lantern in house rig (focus is fixed)
- Lui Flood
- Fixture Number DMX Address

VENUE		Venue 45	
TITLE		LIGHTING Plan	
SIZE	DWG NO	REV	
A4	theSpaceUK-VP-01-18	23.1	
SCALE	SHEET		